
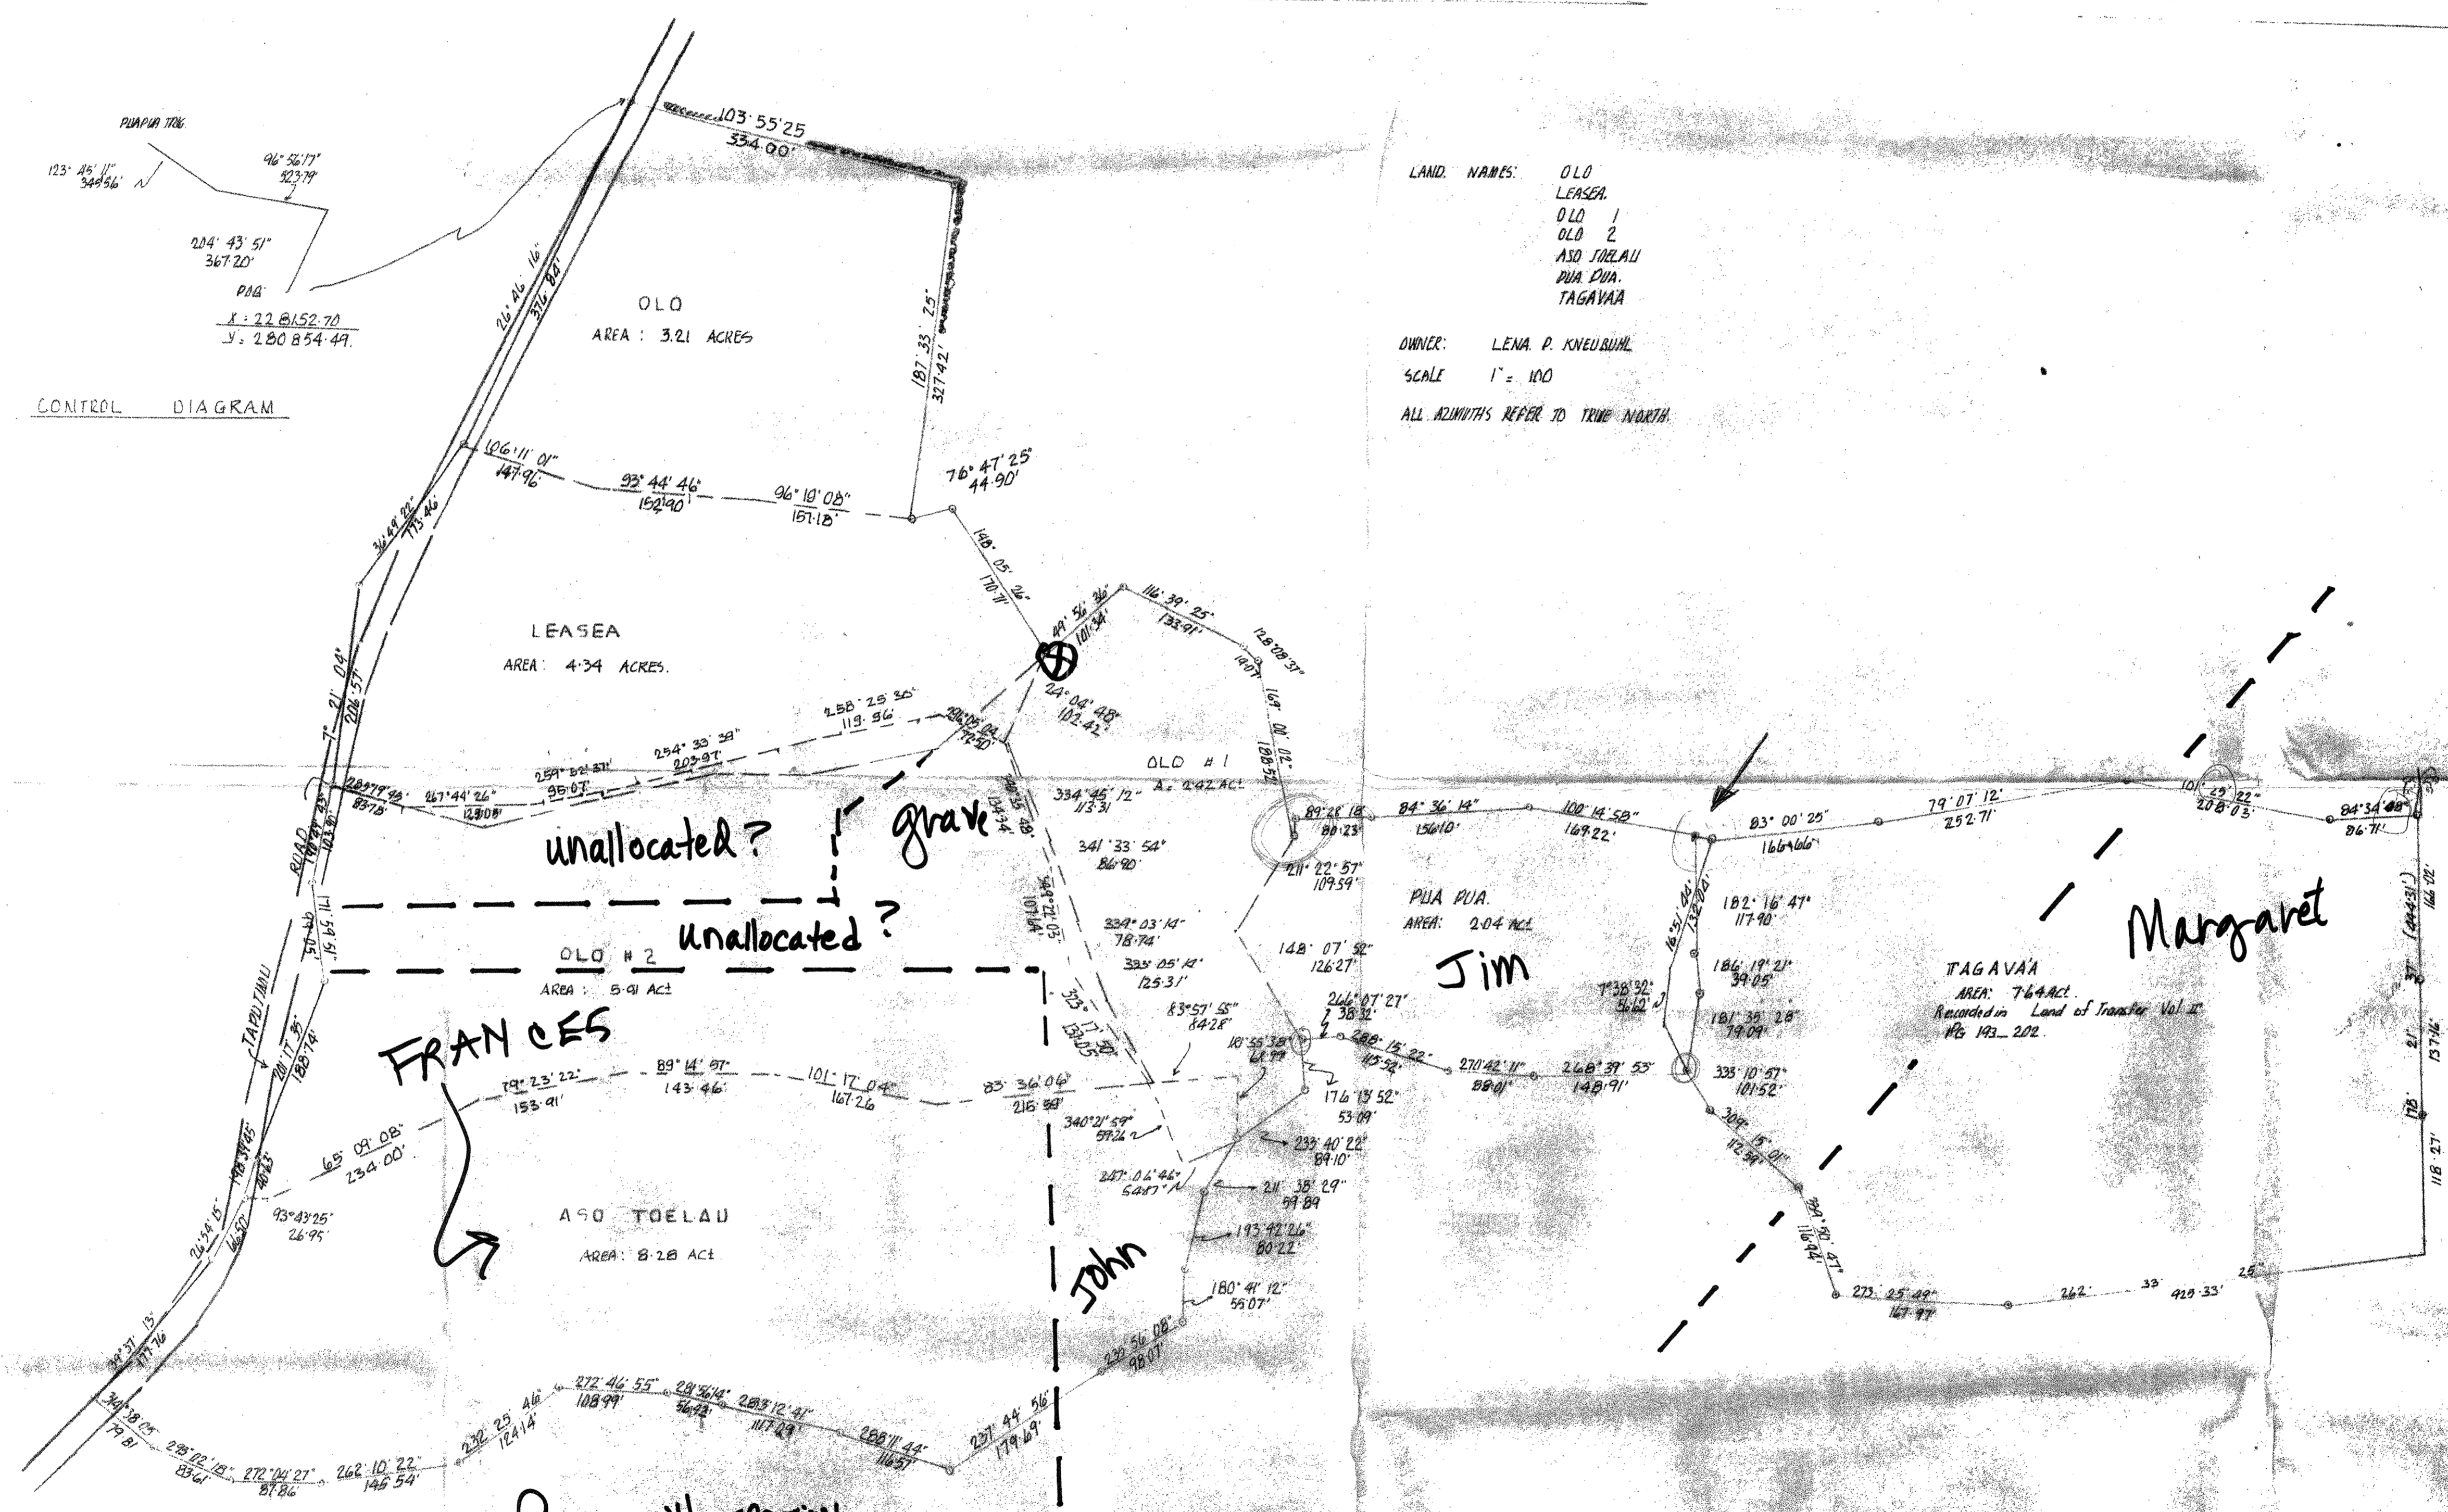


PUMP HOUSE  
 123° 45' 11" 349.56'  
 96° 56' 17" 523.79'  
 204° 43' 51" 367.20'  
 P.M.G.  
 X: 22 8152.70  
 Y: 280 854.44  
 CONTROL DIAGRAM

LAND NAMES:  
 OLO  
 LEASEA  
 OLO #1  
 OLO #2  
 ASO TOELAU  
 PUA PUA  
 TAGAVAA

OWNER: LENA P. KNEUBUHL  
 SCALE 1" = 100'  
 ALL AZIMUTHS REFER TO TRUE NORTH.

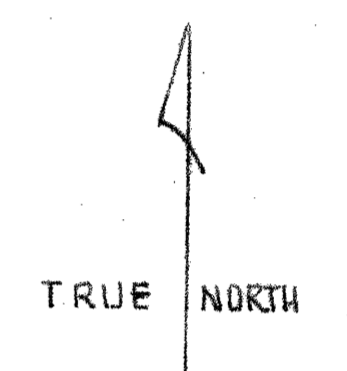

ROBIN'S ILLUSTRATION  
 1/13/2014

THIS IS CERTIFIED TO BE TRUE COPY OF ORIGINAL  
 W. H. [Signature] 1/23/95  
 GENERAL MANAGER OF LAND SURVEY DIVISION