


PUMPUP TIRE  
 123° 48' 11" 348.56  
 96° 56' 17" 523.79  
 204° 43' 51" 367.20  
 P1A  
 X: 22 8152.70  
 Y: 280 854.49

CONTROL DIAGRAM

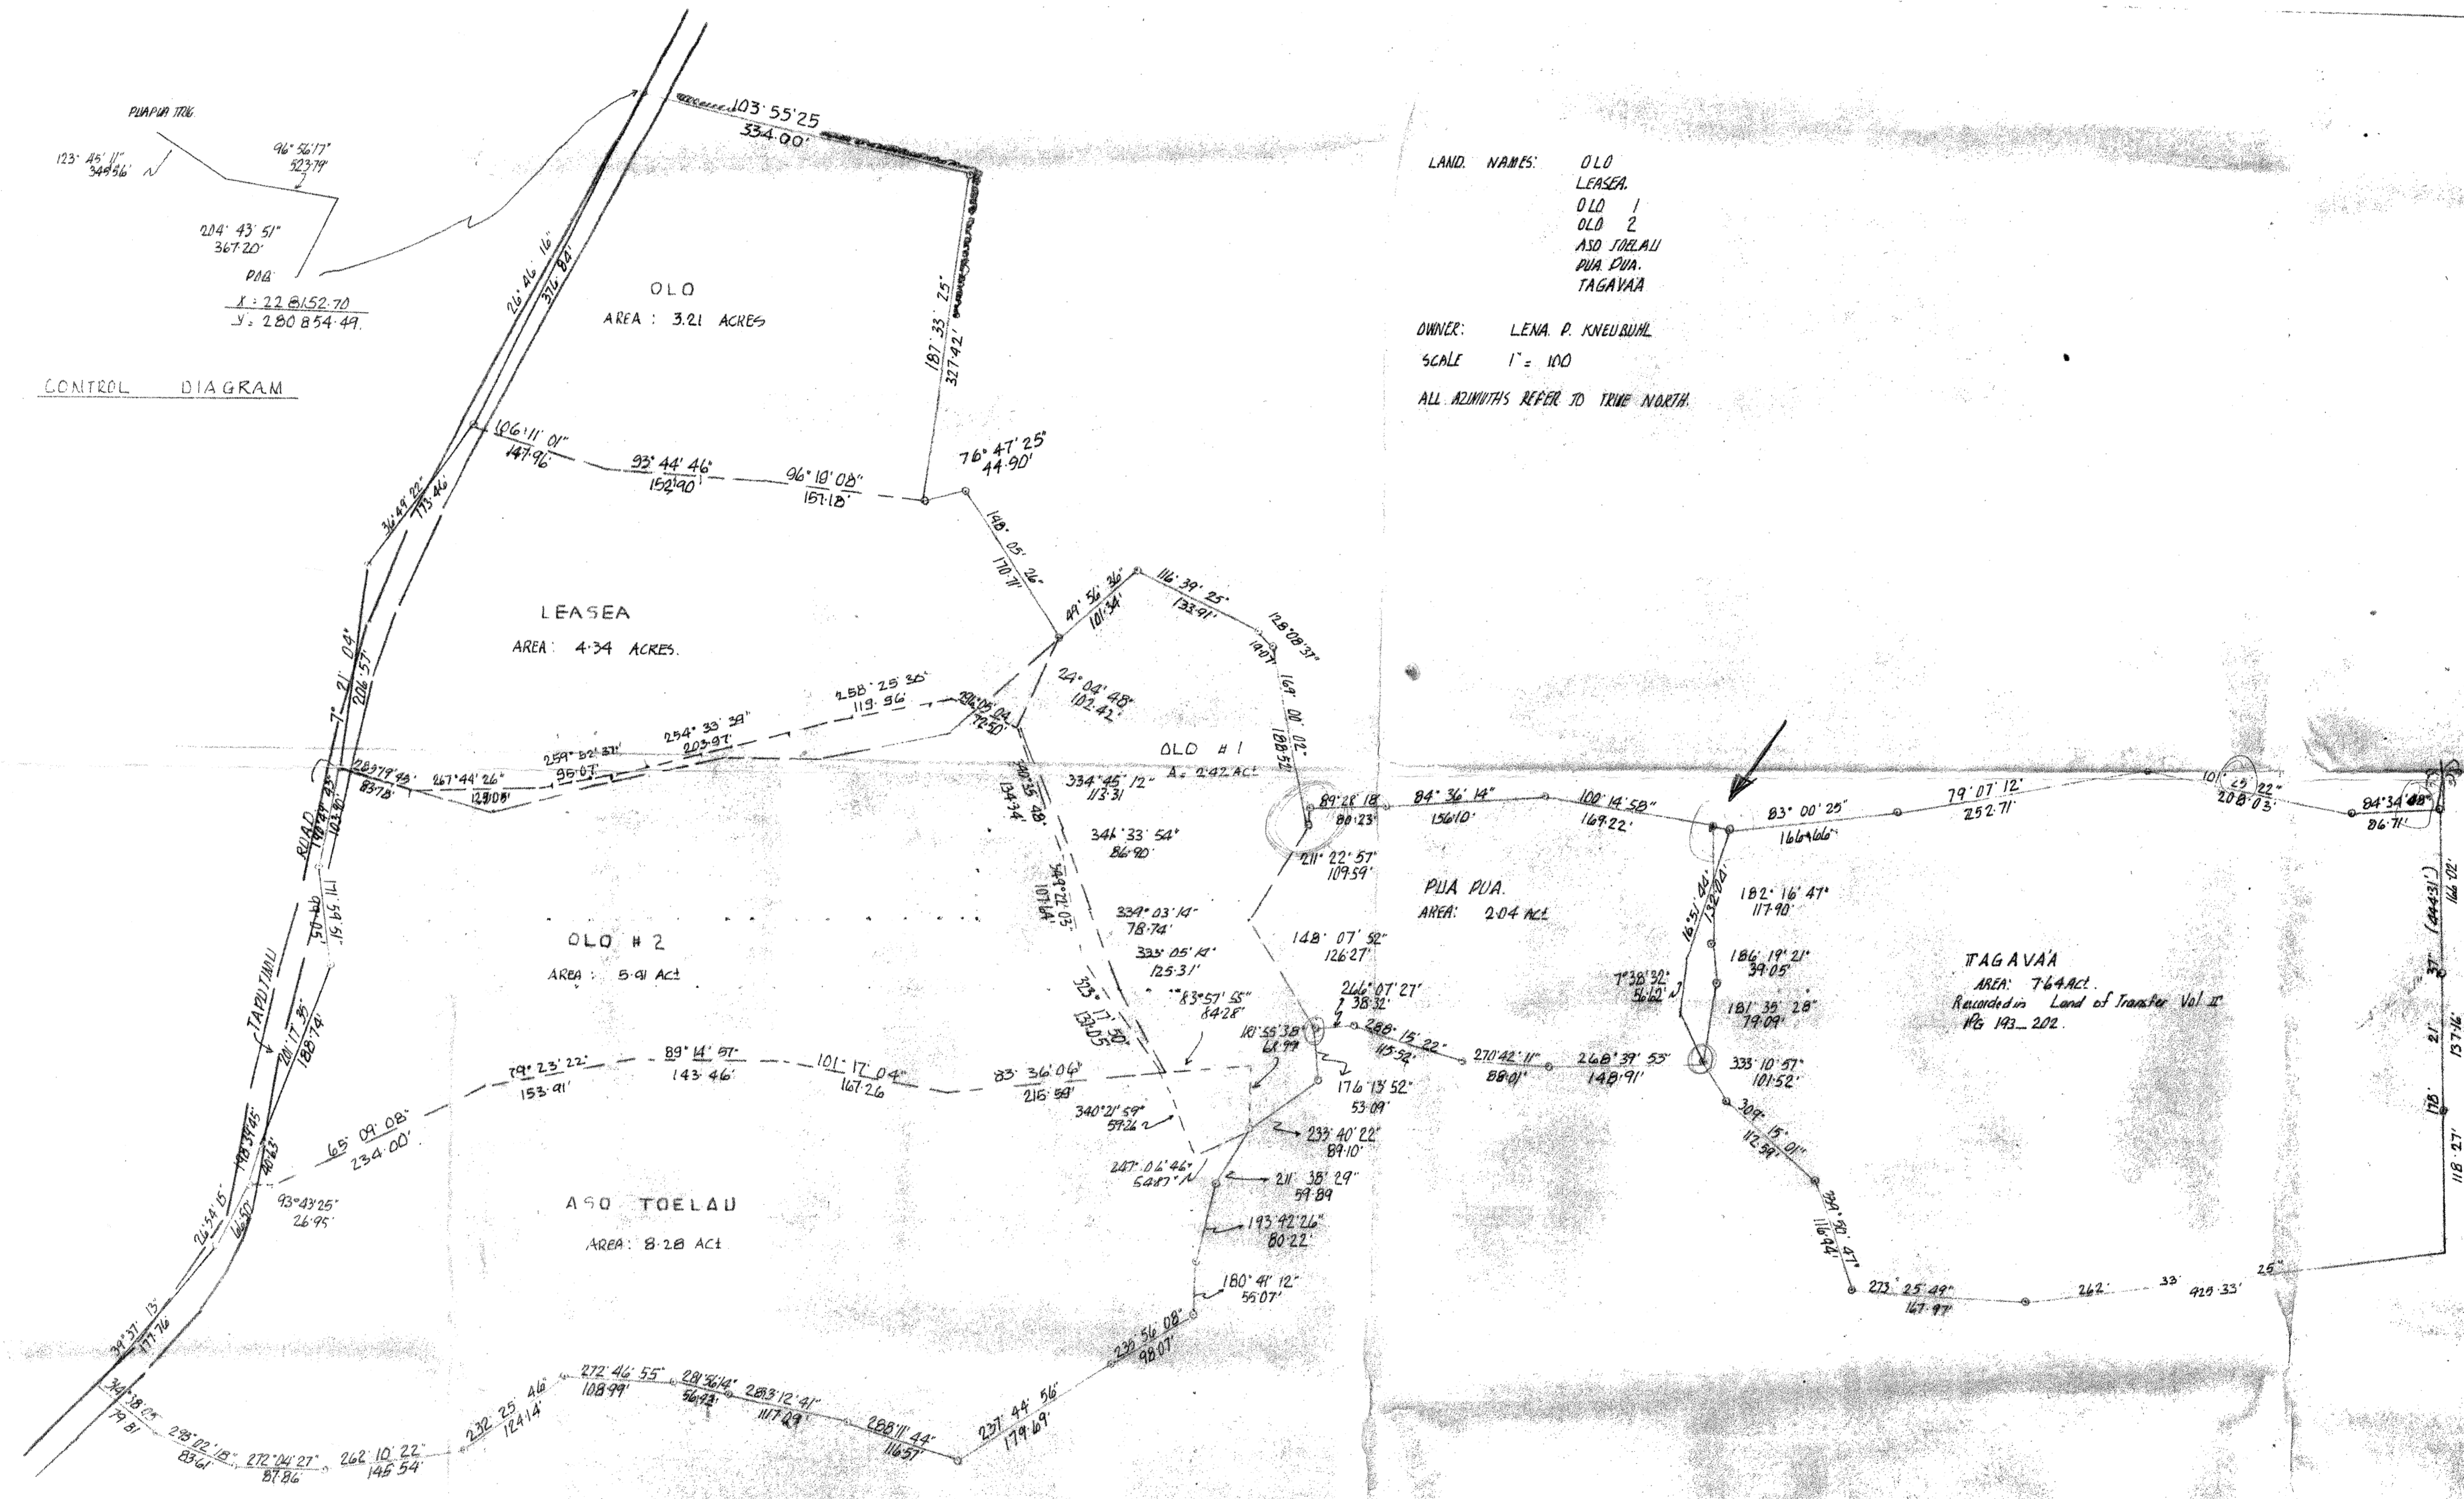

LAND NAMES:  
 OLO  
 LEASEA  
 OLO 1  
 OLO 2  
 ASO TOELAU  
 PUA PUA  
 TAGAVAA

OWNER: LENA P. KNEUBAHL  
 SCALE 1" = 100'  
 ALL AZIMUTHS REFER TO TRUE NORTH.

THIS IS CERTIFIED TO BE TRUE COPY OF ORIGINAL  
 APPROVED: *[Signature]* 1/23/95  
 GENERAL MANAGER OF LANDS & SURVEY DIVISION